


SANITARY WASTE & VENT
PLUMBING PIPES IN
THIS WALL/CHASE

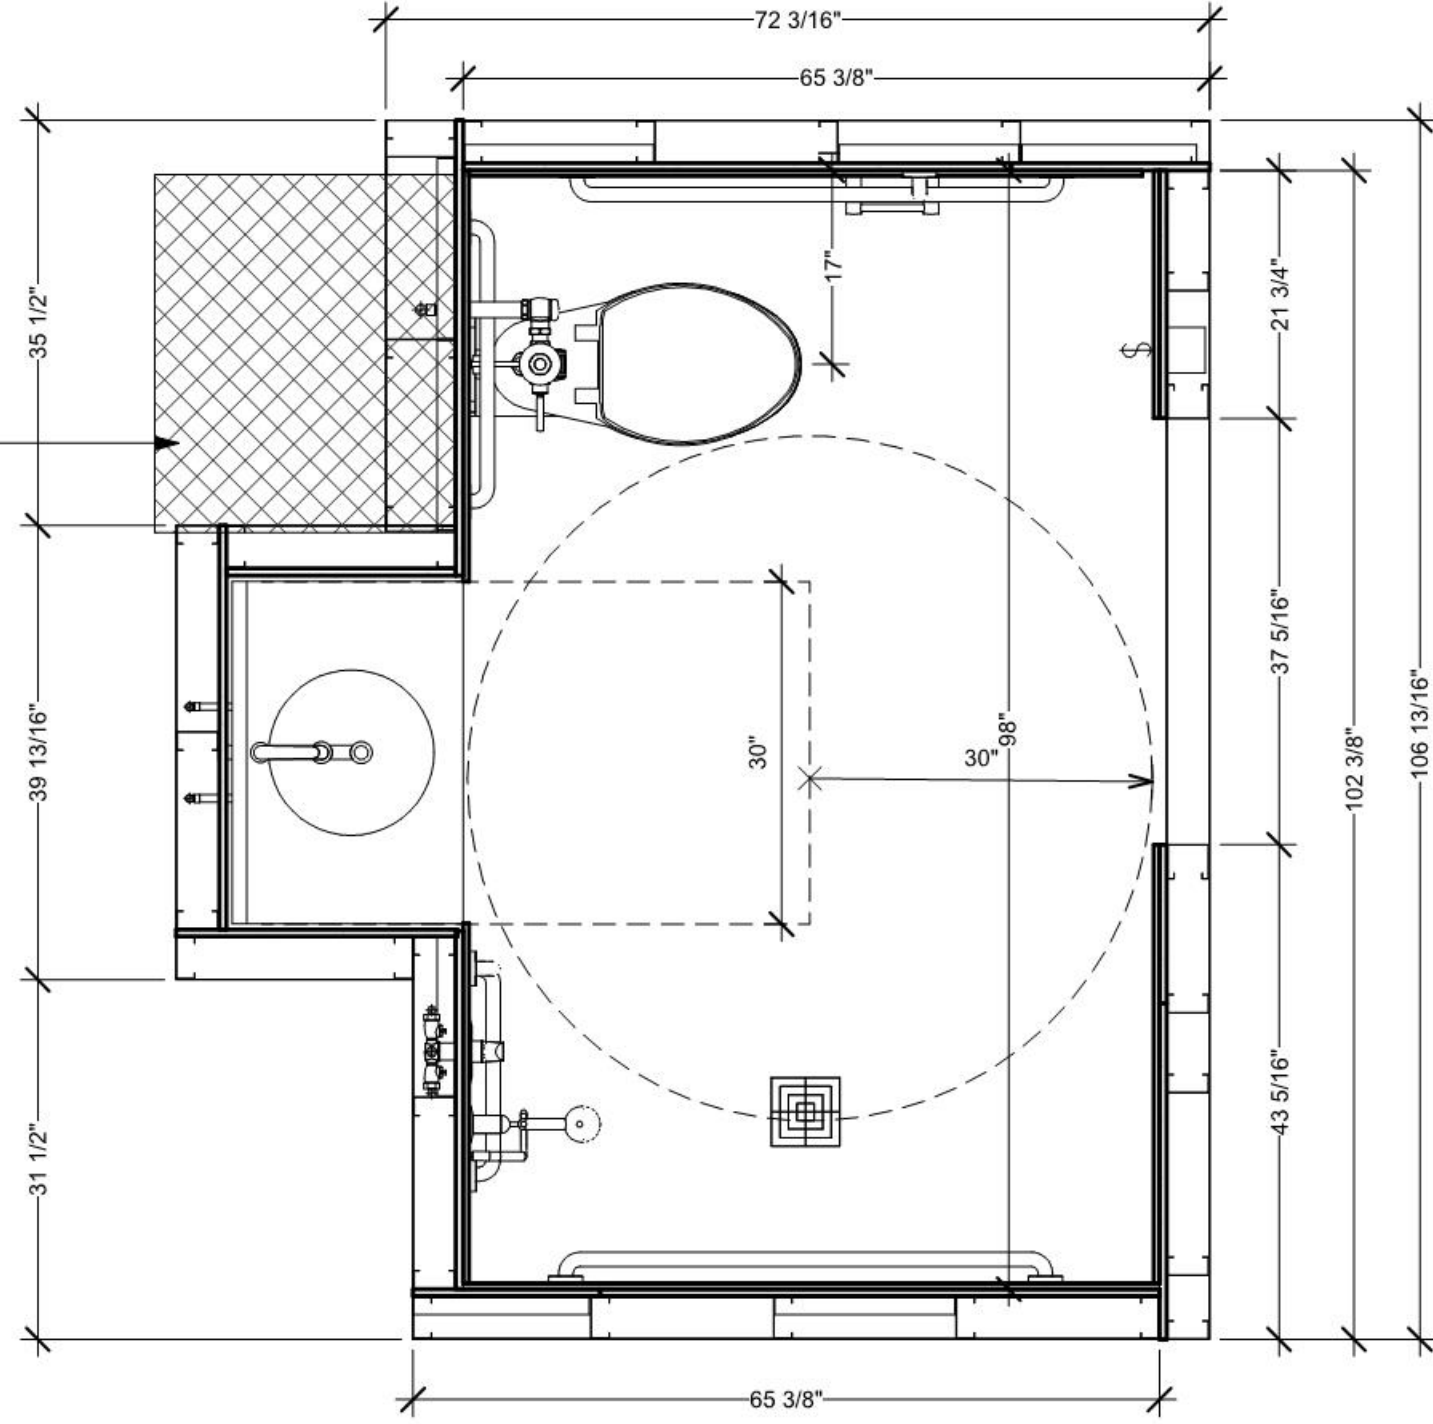

No.	Date

FLOOR PLAN

SHEET

PIVOTEK PROJECT NUMBER

DATE

DRAWN BY

Owner

PROJECT NUMBERS:

Issue Date

ACCESSIBLE HOSPITAL PATIENT
BATHROOM 1

PIVOTEK

HOW TOMORROW BUILDS.

A-1.0