


SANITARY WASTE & VENT
PLUMBING PIPES IN
THIS WALL

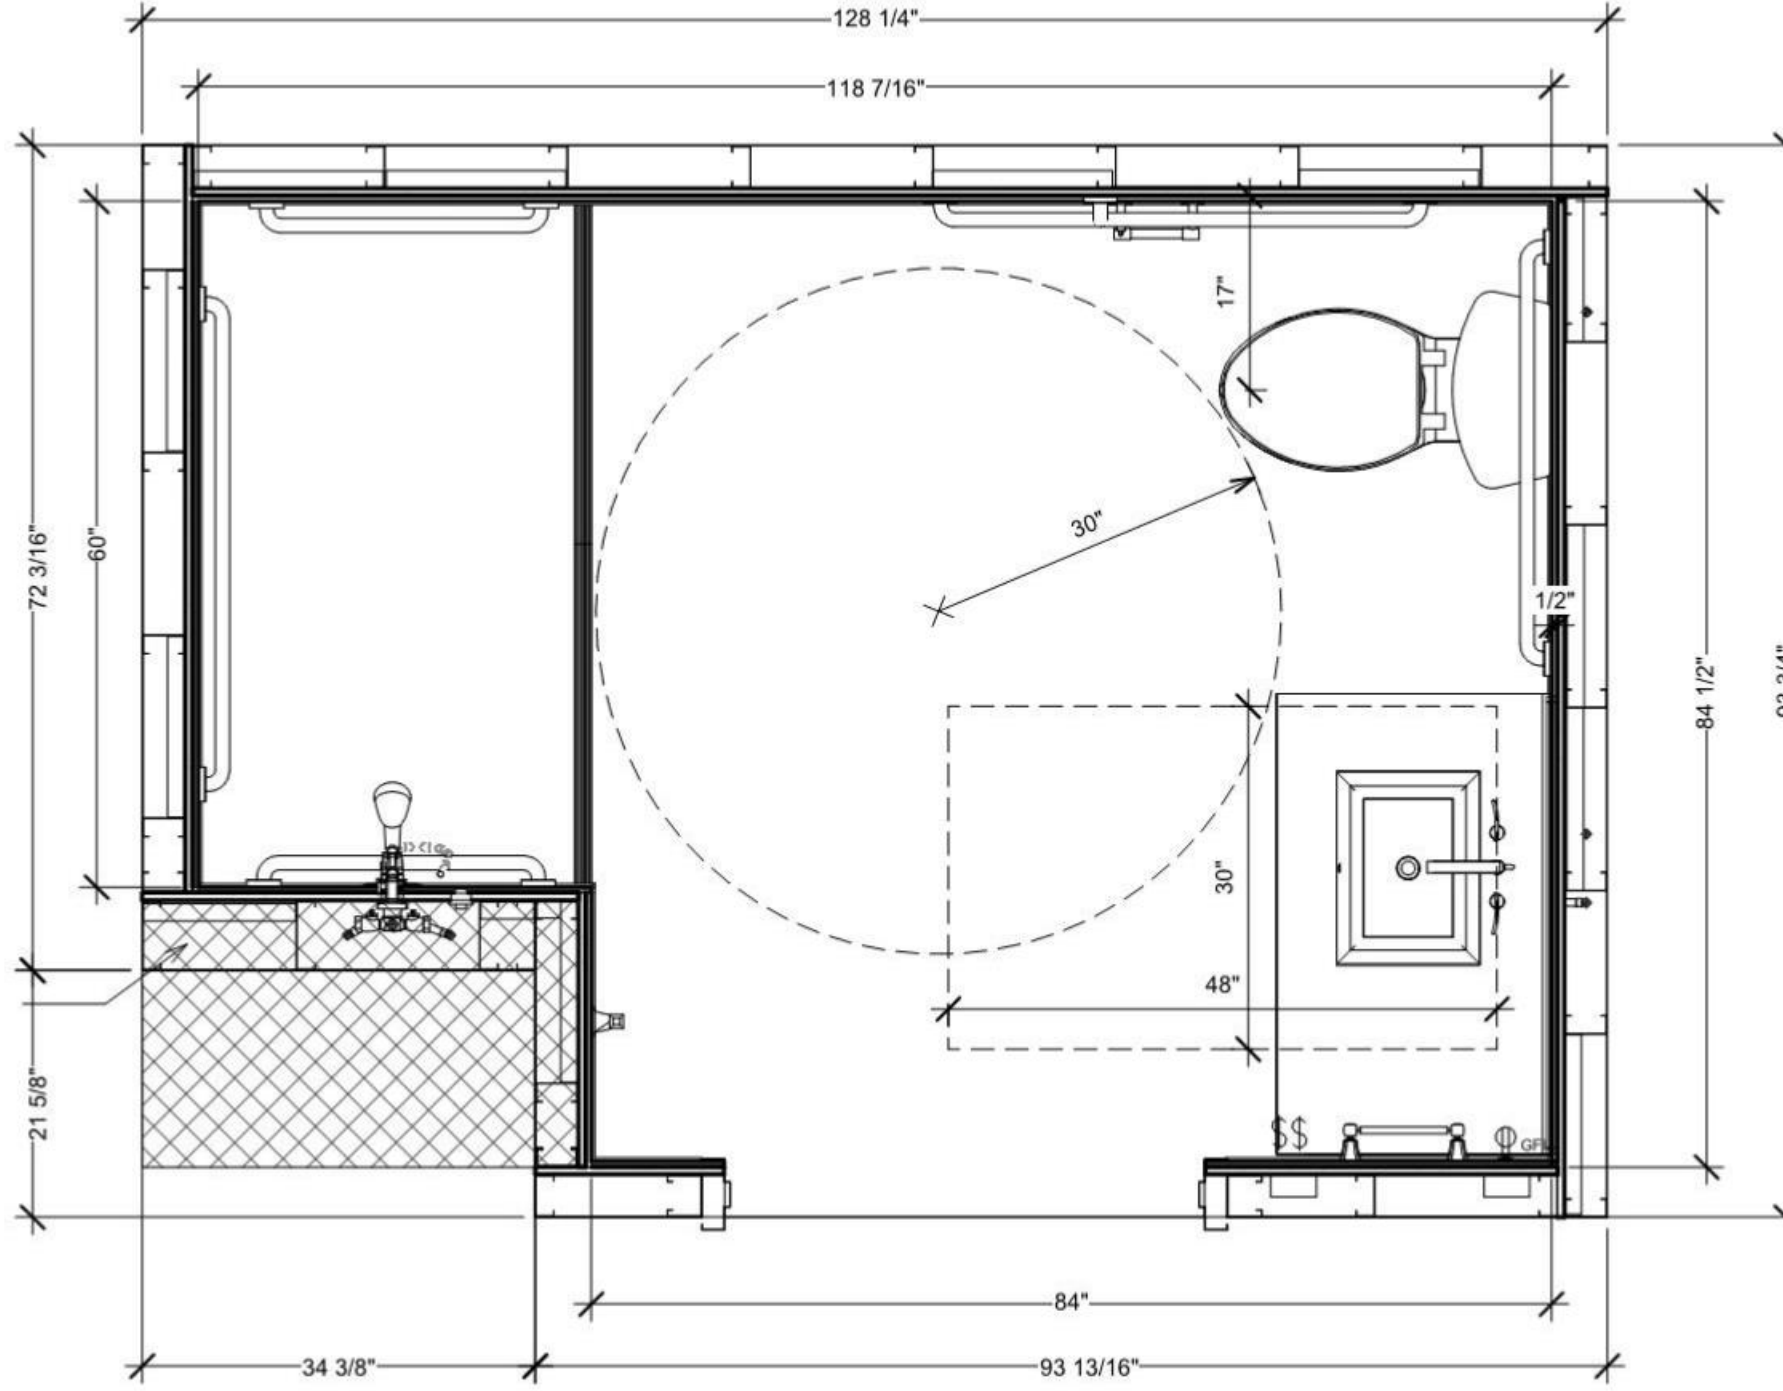

No.	Date

FLOOR PLAN
SHEET
PIVOTEK PROJECT NUMBER
DATE
ISSUE DATE
DRAWN BY
A-1.0

ACCESSIBLE HOTEL BATHROOM



PIVOTEK
PROJECT NUMBERS: